

Client: THE BUBBLE BATH CAR WASH
Address: 3726 S. NEW BRAUNFELS
Location: SAN ANTONIO, TX 78223
Sales: GW
Designer: RH
Date: 02.16.16
PM JMD

This is an original drawing created by Walton. It is submitted for your personal use, however, it shall at all times remain the property of Walton. It may be used in connection with the project being planned for you by Walton, but not otherwise. You are not authorized to show these drawings to anyone outside your organization, nor is it to be reproduced, used, copied or exhibited in any fashion.

Revision:

Path: _____

Signs will be manufactured with 120 Volts A/C. All Primary electrical service to the sign and final connection thereof, is the responsibility of the buyer. All work is to be done in accordance with the purchase agreement attached hereto. In case of variance between the specifications of the purchase agreement and this drawing, the drawing shall prevail.


This sign is intended to be installed in accordance with the requirements of Article 600 of the National Electrical Code and/or other applicable local codes. This includes proper grounding and bonding of the sign.

Approvals:
Sales: _____
P.M.: _____
Design: _____
Client: _____


Date: _____
Date: _____
Date: _____
Date: _____

CID149063

201 SQ. FEET

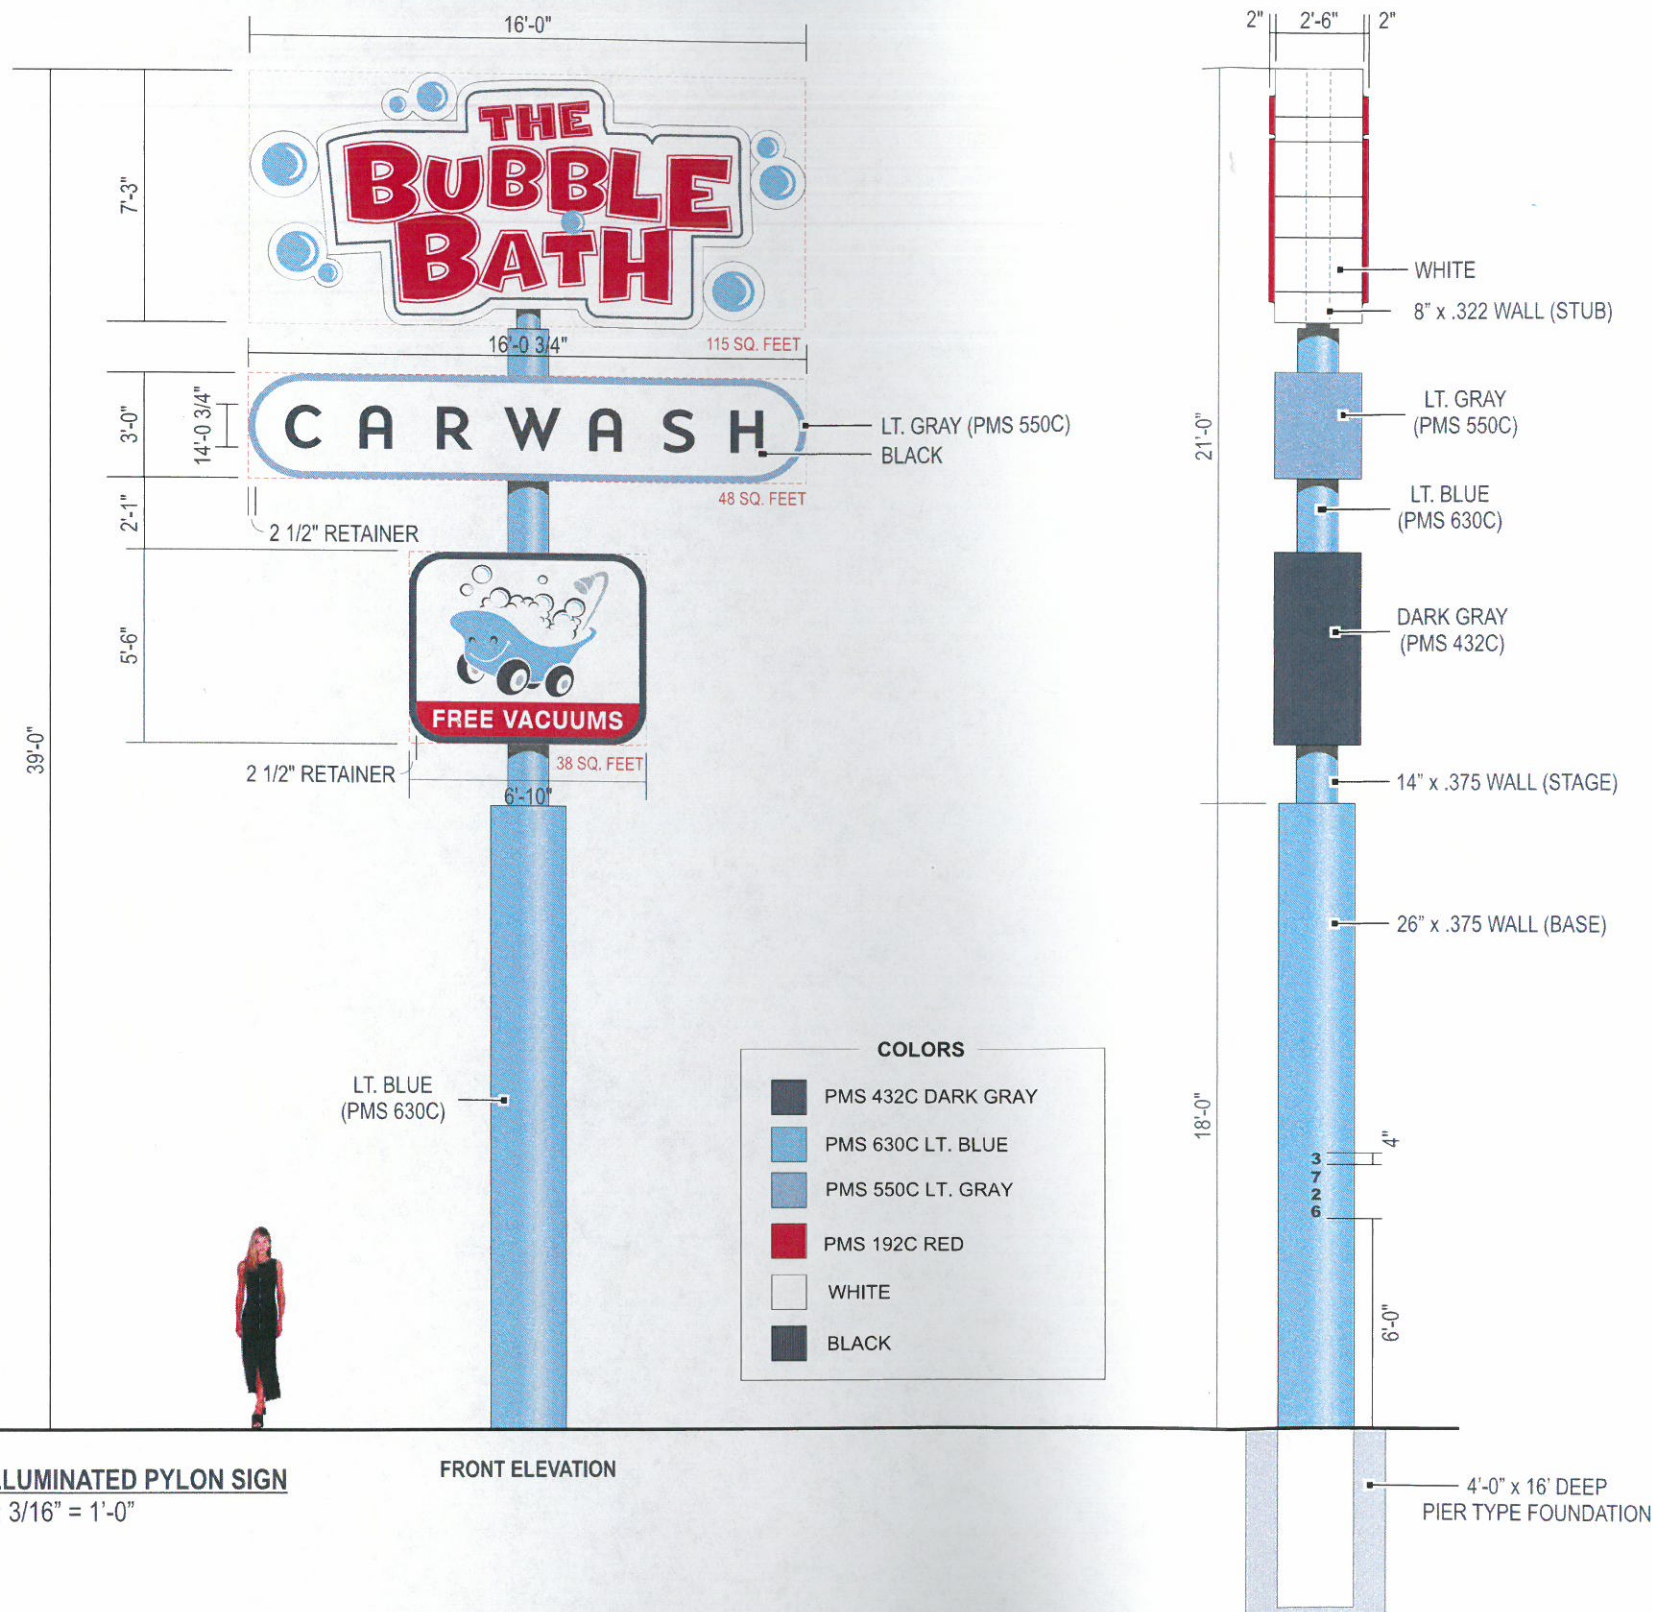

OPPOSITE VIEW
SIGN FACE (NTS)

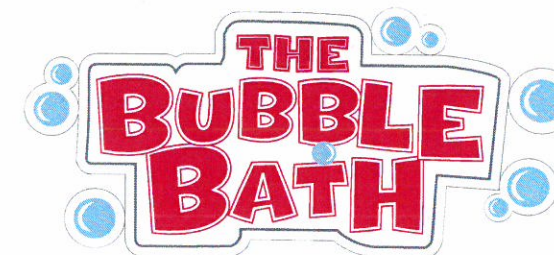

SCOPE OF WORK:

MANUFACTURE AND INSTALL (2) TWO D/F ILLUMINATED PYLON SIGN

DETAILS:

"BUBBLE BATH"

FABRICATED ALUMINUM CABINET
PAN FORMED AND EMBOSSED FACE WITH PAINTED GRAPHICS SECOND SURFACE
ILLUMINATED W/ HO FLUORESCENT LAMPS

"CAR WASH"

FABRICATED ALUMINUM CABINET
3/16" 7328 WHITE ACRYLIC FACE WITH VINYL GRAPHICS
ILLUMINATED W/ HO FLUORESCENT LAMPS

"VACUUMS"

FABRICATED ALUMINUM CABINET
3/16" 7328 WHITE ACRYLIC FACE WITH VINYL GRAPHICS
ILLUMINATED W/ HO FLUORESCENT LAMPS

ENGINEERING NOTE:

SUPPORT AND FOOTING SPECIFICATIONS
HEREIN TO BE VERIFIED AND SEALED BY
A CERTIFIED STRUCTURAL ENGINEER.

B D/F ILLUMINATED PYLON SIGN
Scale: 3/16" = 1'-0"

FRONT ELEVATION



Client: THE BUBBLE BATH CAR WASH
Address: 3726 S. NEW BRAUNFELS
Location: SAN ANTONIO, TX 78223
Sales: GW
Date: 02.16.16
Designer: RH
PM: JMD

This is an original drawing created by Walton. It is submitted for your personal use, however, it shall at all times remain the property of Walton. It may be used in connection with the project being planned for you by Walton, but not otherwise. You are not authorized to show these drawings to anyone outside your organization, nor is it to be reproduced, used, copied or exhibited in any fashion.

Revision:

Path:

Signs will be manufactured with 120 Volts A/C. All Primary electrical service to the sign and final connection thereof, is the responsibility of the buyer. All work is to be done in accordance with the purchase agreement attached hereto. In case of variance between the specifications of the purchase agreement and this drawing, the drawing shall prevail.

This sign is intended to be installed in accordance with the requirements of Article 600 of the National Electrical Code and/or other applicable local codes. This includes proper grounding and bonding of the sign.

Approvals:

Sales:	Date:
P.M.:	Date:
Design:	Date:
Client:	Date:

CID149063

SHEET 2 OF 2